


ROOF ELECTRICAL & MECHANICAL PLAN

SCALE: 1/4"=1'-0"

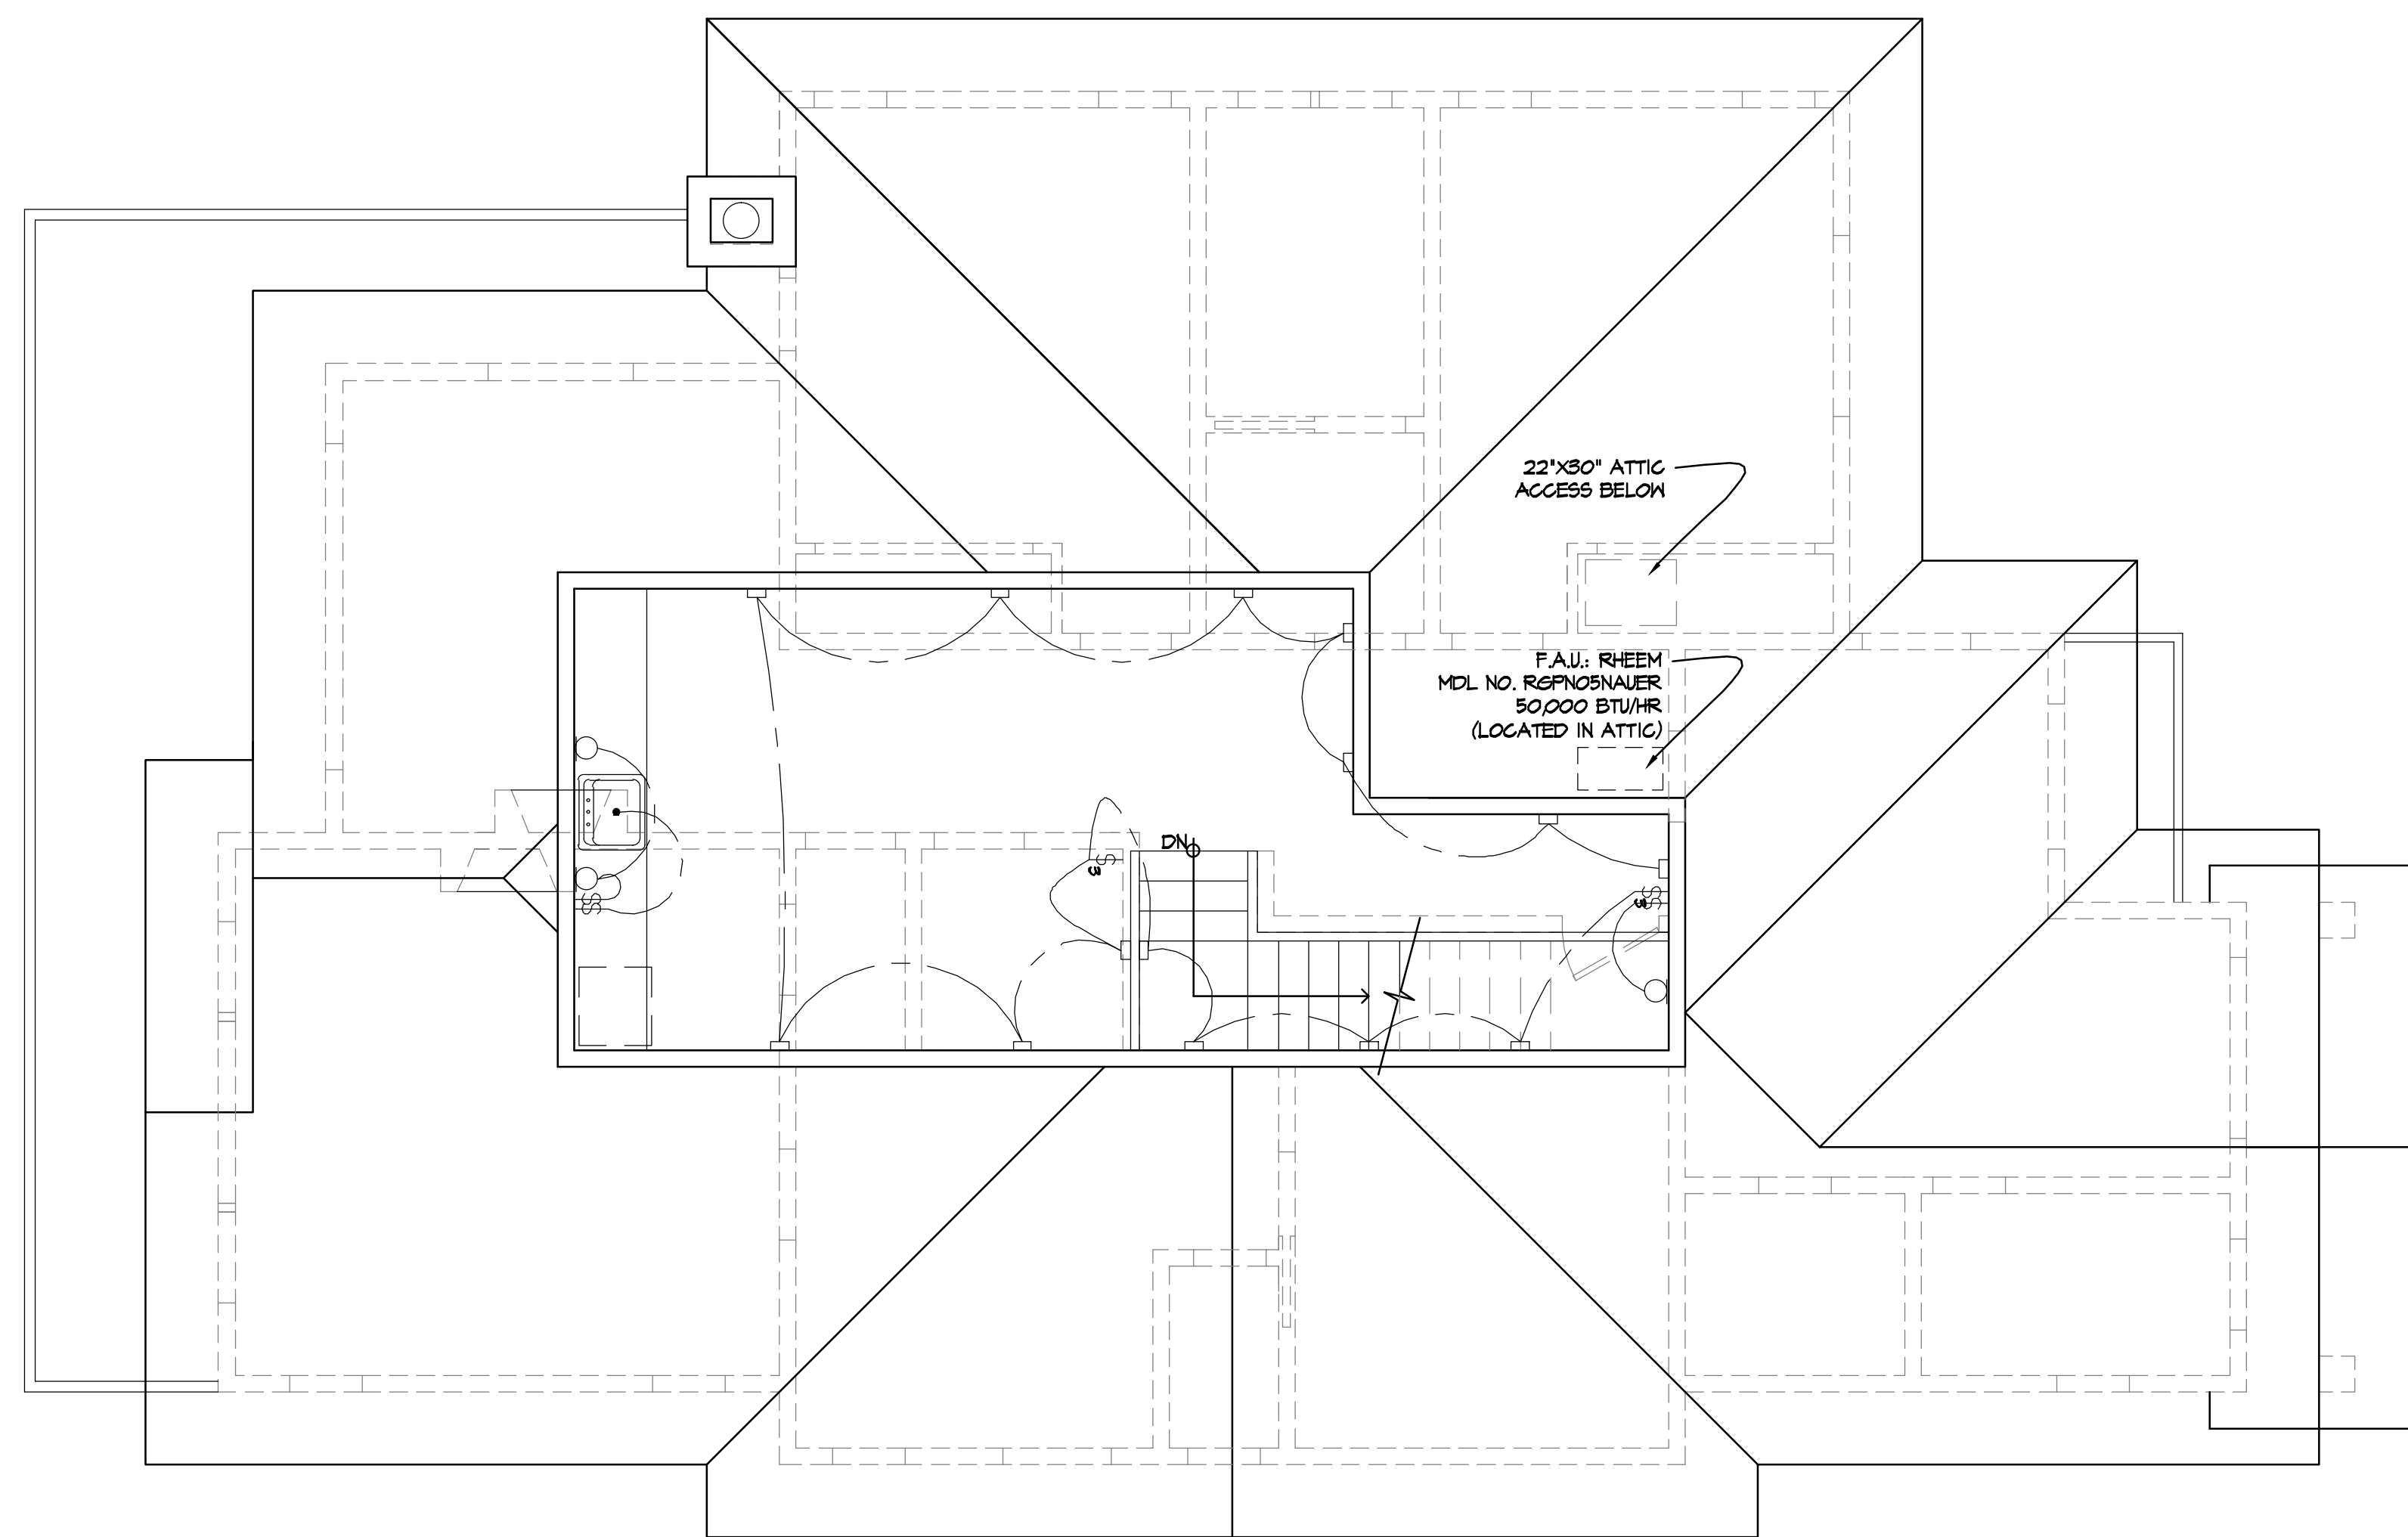

ROOF LIGHTING PLAN

SCALE: 1/4"=1'-0"



ARCHITECT MARK D. LYON INC.
 410 BIRD ROCK AVE., LA JOLLA, CA. 92037 (858)459-1171 INFO@MDLA.NET



MEBUST RESIDENCE
 5448 TAFT AVE
 LA JOLLA, CA 92037

REVISIONS:
SUBMITTAL DATE: 09.30.2013
PHASE: CONSTRUCTION DOCUMENTS
PROJECT NUMBER: 1306
REVIEWED BY: MDL
DRAWN BY: SEH
DATE: 09.30.2013
SHEET TITLE: ROOF MECHANICAL, ELECTRICAL & LIGHTING PLAN SHEET NO.:

ME1.4

All design, construction and appearance are subject to these drawings and specifications. No part of these drawings or specifications shall be used for any other project without the express written consent of Architect Mark D. Lyon, Inc. AIA. It is prohibited. There shall be no change or deviation from these drawings or specifications without the express written consent of Architect Mark D. Lyon, Inc. AIA. All design, construction and appearance are subject to these drawings and specifications. No part of these drawings or specifications shall be used for any other project without the express written consent of Architect Mark D. Lyon, Inc. AIA. It is prohibited. There shall be no change or deviation from these drawings or specifications without the express written consent of Architect Mark D. Lyon, Inc. AIA.