



**SECOND FLOOR ELECTRICAL & MECHANICAL PLAN**  
 SCALE: 1/4"=1'-0"

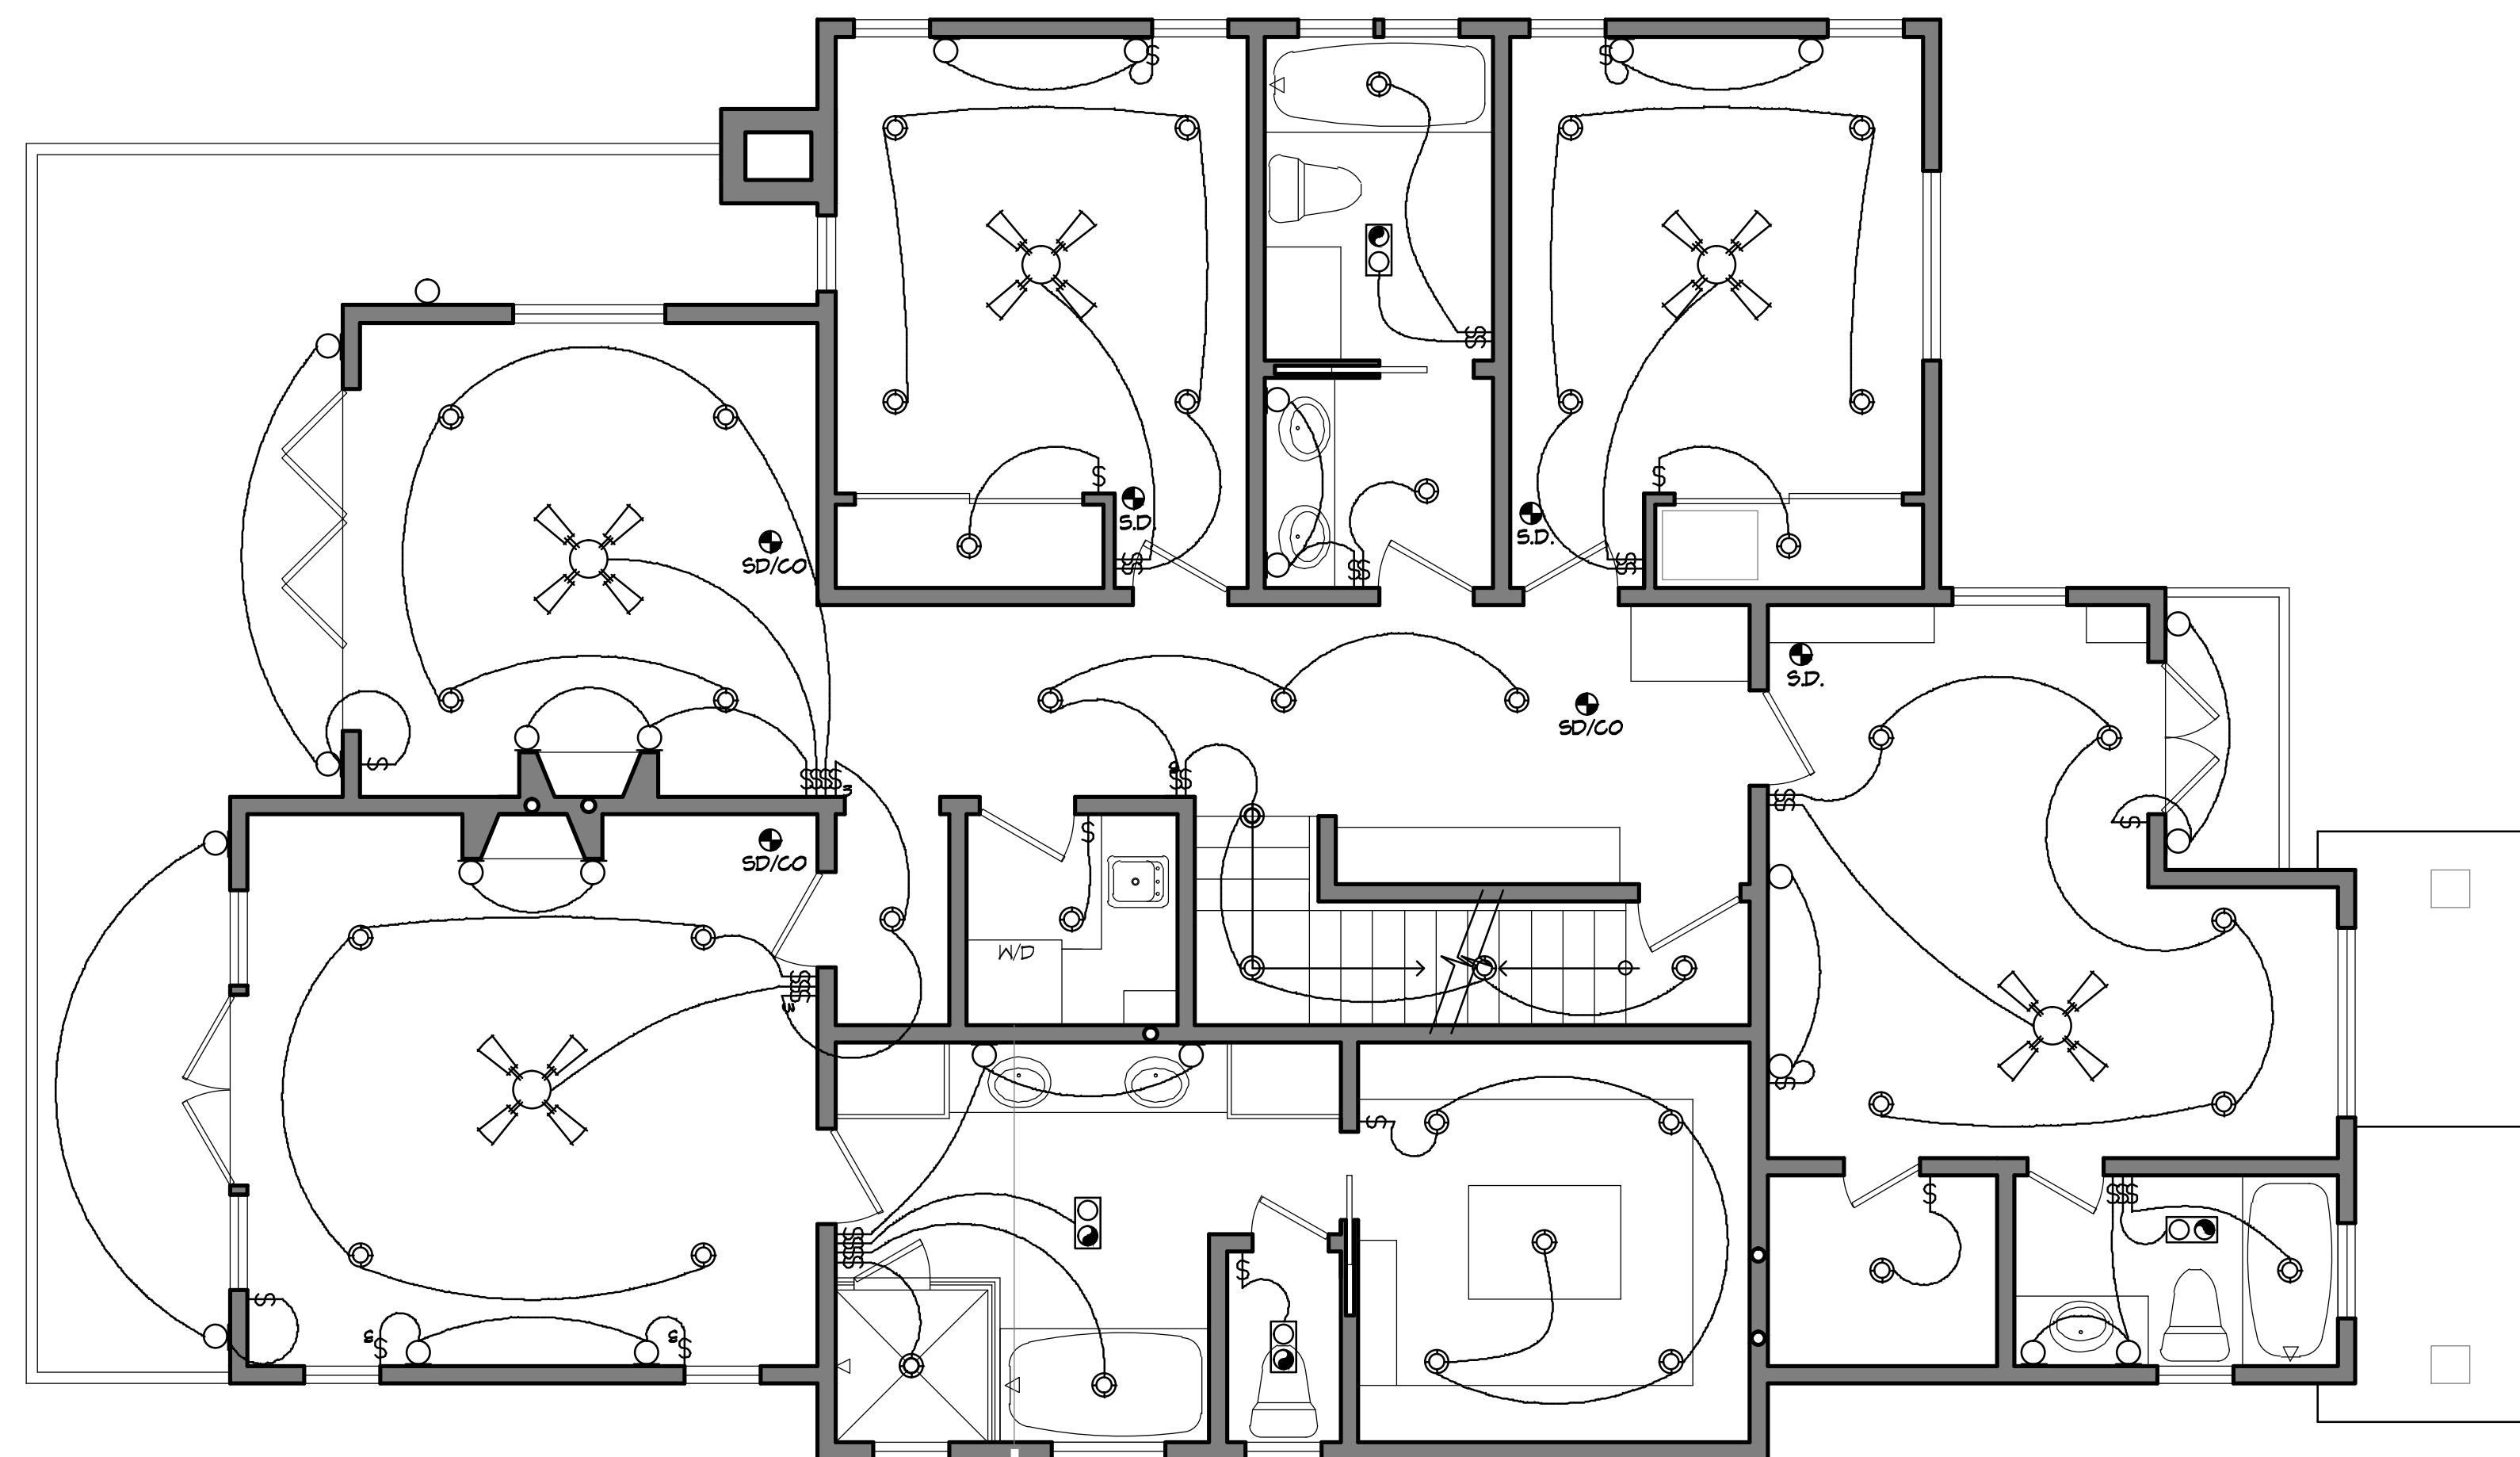

**SECOND FLOOR LIGHTING PLAN**  
 SCALE: 1/4"=1'-0"

**ARCHITECT MARK D. LYON INC.**  
 410 BIRD ROCK AVE., LA JOLLA, CA. 92037 (858)459-1171 INFO@MDLA.NET

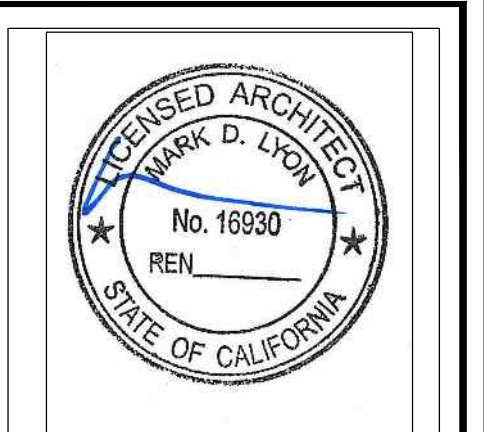

**MEBUST RESIDENCE**  
 5448 TAFT AVE  
 LA JOLLA, CA 92037

REVISIONS:
SUBMITTAL DATE: 09.30.2013
PHASE: CONSTRUCTION DOCUMENTS
PROJECT NUMBER: 1306
REVIEWED BY: MDL
DRAWN BY: SEH
DATE: 09.30.2013
SHEET TITLE: SECOND FLOOR MECHANICAL, ELECTRICAL & LIGHTING PLAN SHEET NO.:
<b>ME1.3</b>

All design, codes and all agreements are the legal property of Architect Mark D. Lyon, Inc. & the original use and specific project for which they were prepared. Reproduction, distribution, or use for any other project or purpose without the express written consent of Architect Mark D. Lyon, Inc. is prohibited. There shall be no change or deviation from these drawings or specifications without the consent of Architect Mark D. Lyon, Inc. Visit our website at www.markdlyon.com for more information.