


FIRST FLOOR ELECTRICAL & MECHANICAL PLAN

SCALE: 1/4"=1'-0"

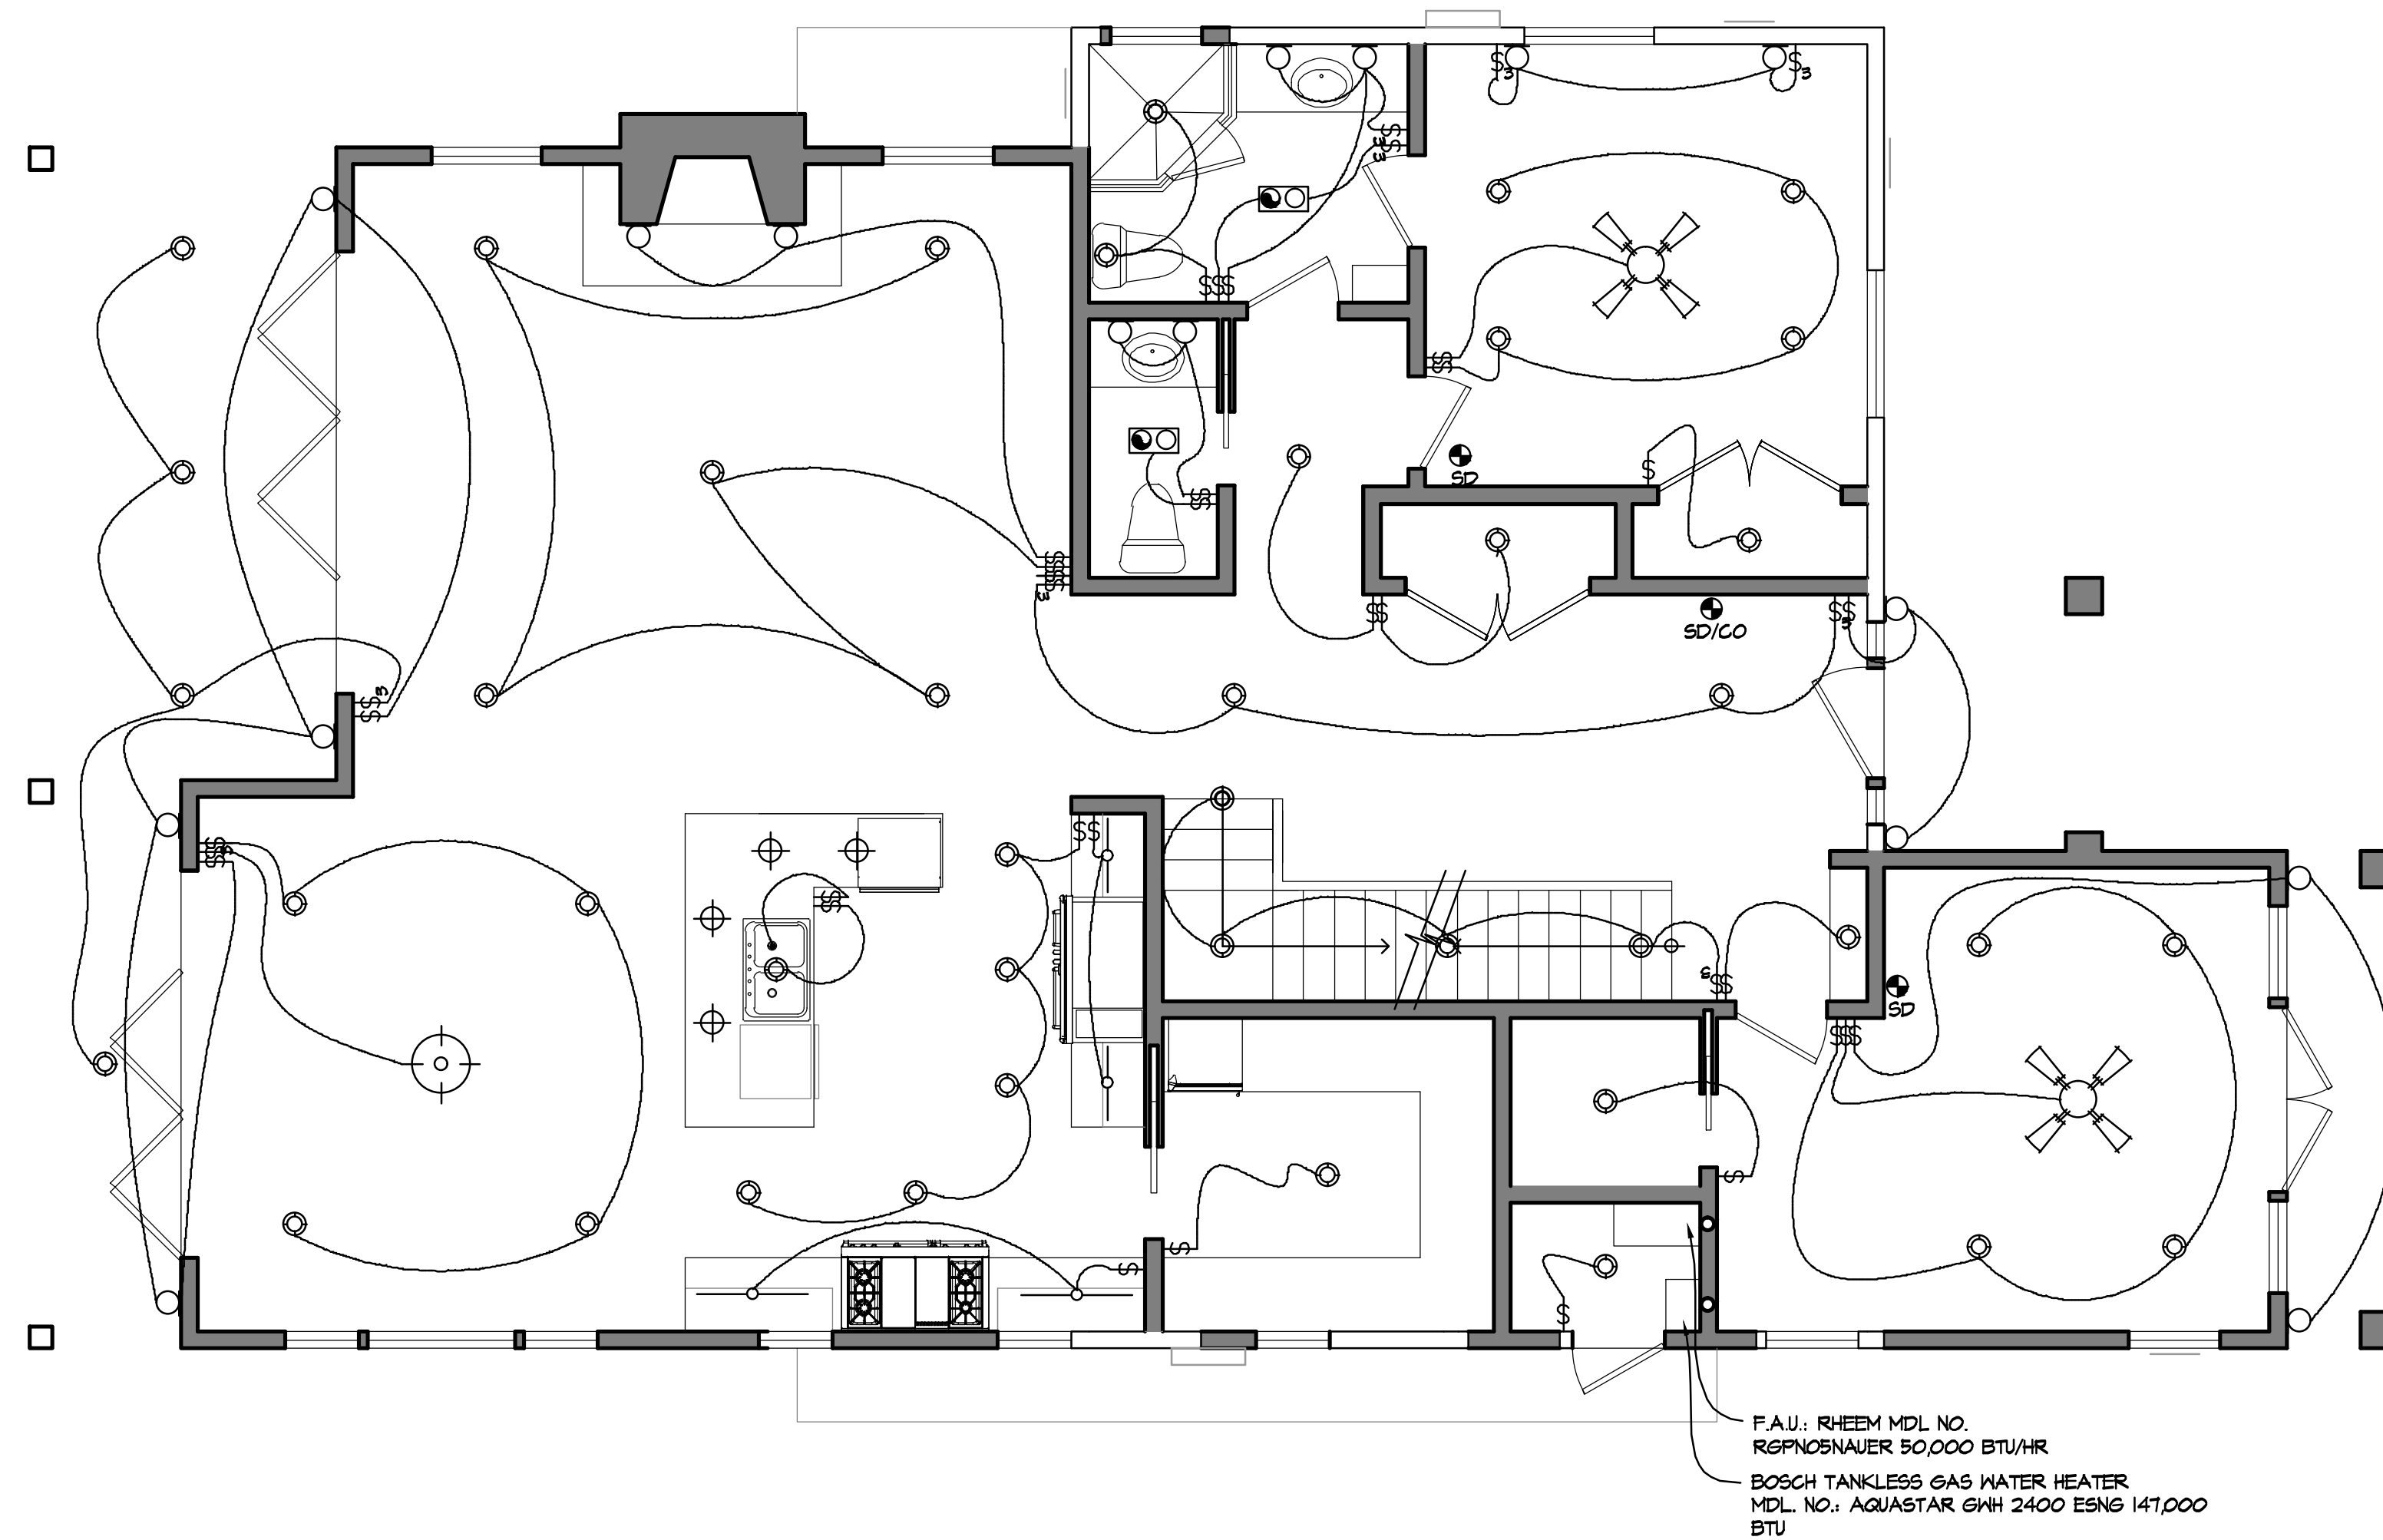


FIRST FLOOR LIGHTING PLAN

SCALE: 1/4"=1'-0"

F.A.U.: RHEEM MDL NO.
RSPINDNAUER 50,000 BTU/HR
BOSCH TANKLESS GAS WATER HEATER
MDL. NO.: AQUASTAR 6WH 2400 ESN6 141,000
BTU

F.A.U.: RHEEM MDL NO.
RSPINDNAUER 50,000 BTU/HR
BOSCH TANKLESS GAS WATER HEATER
MDL. NO.: AQUASTAR 6WH 2400 ESN6 141,000
BTU

ARCHITECT MARK D. LYON INC.
410 BIRD ROCK AVE., LA JOLLA, CA. 92037 (858)459-1171 INFO@MDLA.NET

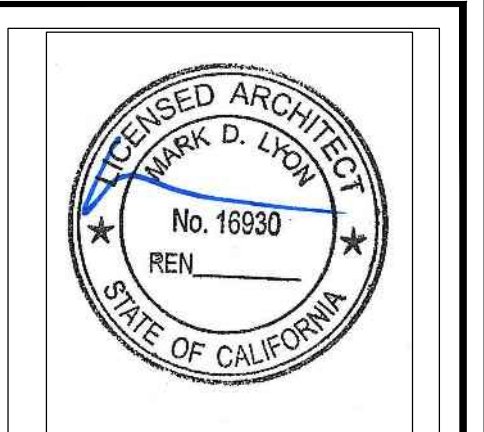

MEBUST RESIDENCE
5448 TAFT AVE
LA JOLLA, CA 92037

REVISIONS:
SUBMITTAL DATE: 09.30.2013
PHASE: CONSTRUCTION DOCUMENTS
PROJECT NUMBER: 1306
REVIEWED BY: MDL
DRAWN BY: SEH
DATE: 09.30.2013
SHEET TITLE: GARAGE MECHANICAL, ELECTRICAL & LIGHTING PLAN SHEET NO.:
ME1.2

All design, plans and all agreements are the legal property of Architect Mark D. Lyon, Inc. & the original set and specific project for which they were prepared. Reproduction, distribution, or use for any other project without the express written consent of Architect Mark D. Lyon, Inc. is prohibited. There shall be no change or deviation from these drawings or specifications without the consent of Architect Mark D. Lyon, Inc. View in context with these drawings and attached specifications shall constitute a complete and accurate set of these instructions and guidelines.